



0m 5m


NOTES:  
01: R/W/P locations TBC

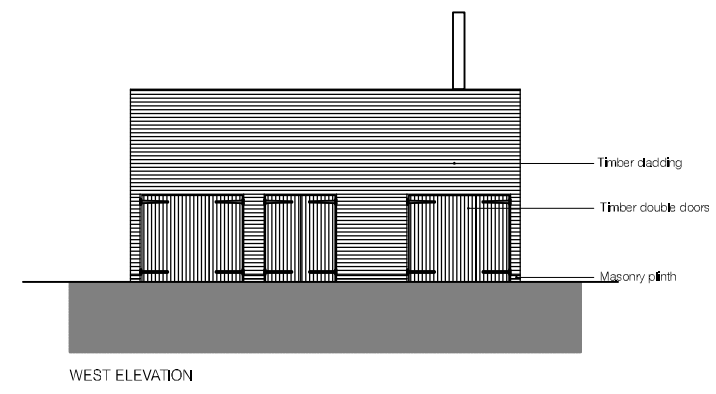


WEST ELEVATION

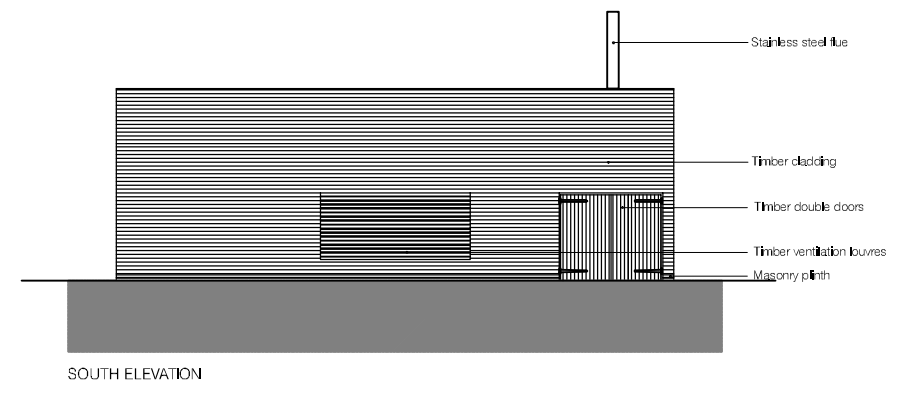

SOUTH ELEVATION

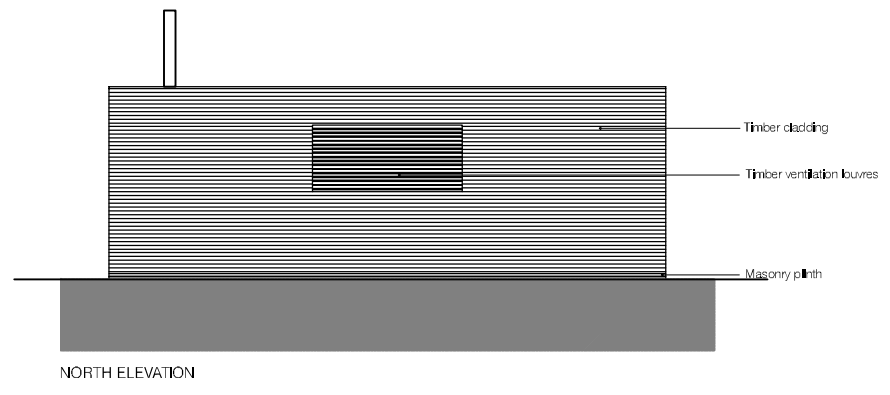

NORTH ELEVATION

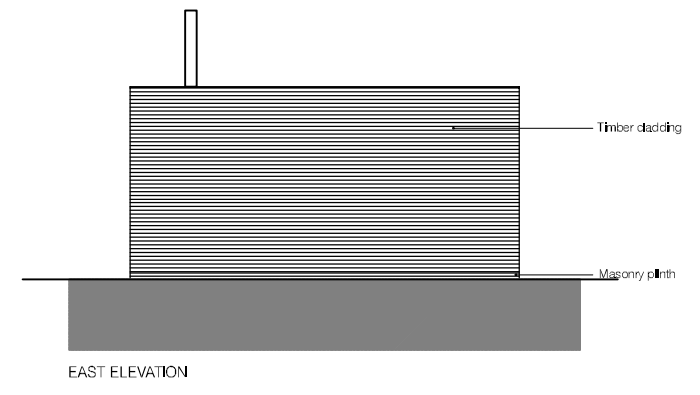

EAST ELEVATION

Issue	Date	By	Checked
-	month 2009	Initial	Initial

Drawing Status: **PRELIMINARY**

Plot ID: new system / drive / 2009 / studio / drawings / paperspace

Scale: 1:100 @ A1 Date: JULY 2009

Job No: 0810 Drawing No: L\_210 Issue: -

Project: WATERFALLS FARM, NORTHUMBERLAND

Title: PROPOSED COMBINED HEAT & POWER PLANT ELEVATIONS  
 clean sheet  
 new asset upon type  
 NE1 1 PG  
 14 0191 251 4436  
 14 0191 222 0201  
 maw@gwkanctectus.co.uk

This drawing is protected by copyright

**GWK**  
 chartered architects